


SPOT REPAIR DATA TABLE				
REPAIR ID	CENTER STATION	NO. LATS	LENGTH	DETAIL
R1	1+49	1	5'	1/CD01
R2	1+89	1	5'	1/CD01
R3	3+33	1	5'	1/CD01
R4	4+73	1	5'	1/CD01

CIPP LINER AS-BUILT TABLE		
MH TO MH SEGMENT	INSTALLED THICKNESS (MM)	INSTALLED SHORT-TERM FLEXURAL MODULUS (PSI)
ABD400-ABD399		
ABD399-ABD398		


TABLE TO BE FILLED IN BY OWNER UPON COMPLETION OF CIPP INSTALLATION

PROFILE: HORIZ: 1"=30'  
VERT: 1"=10'

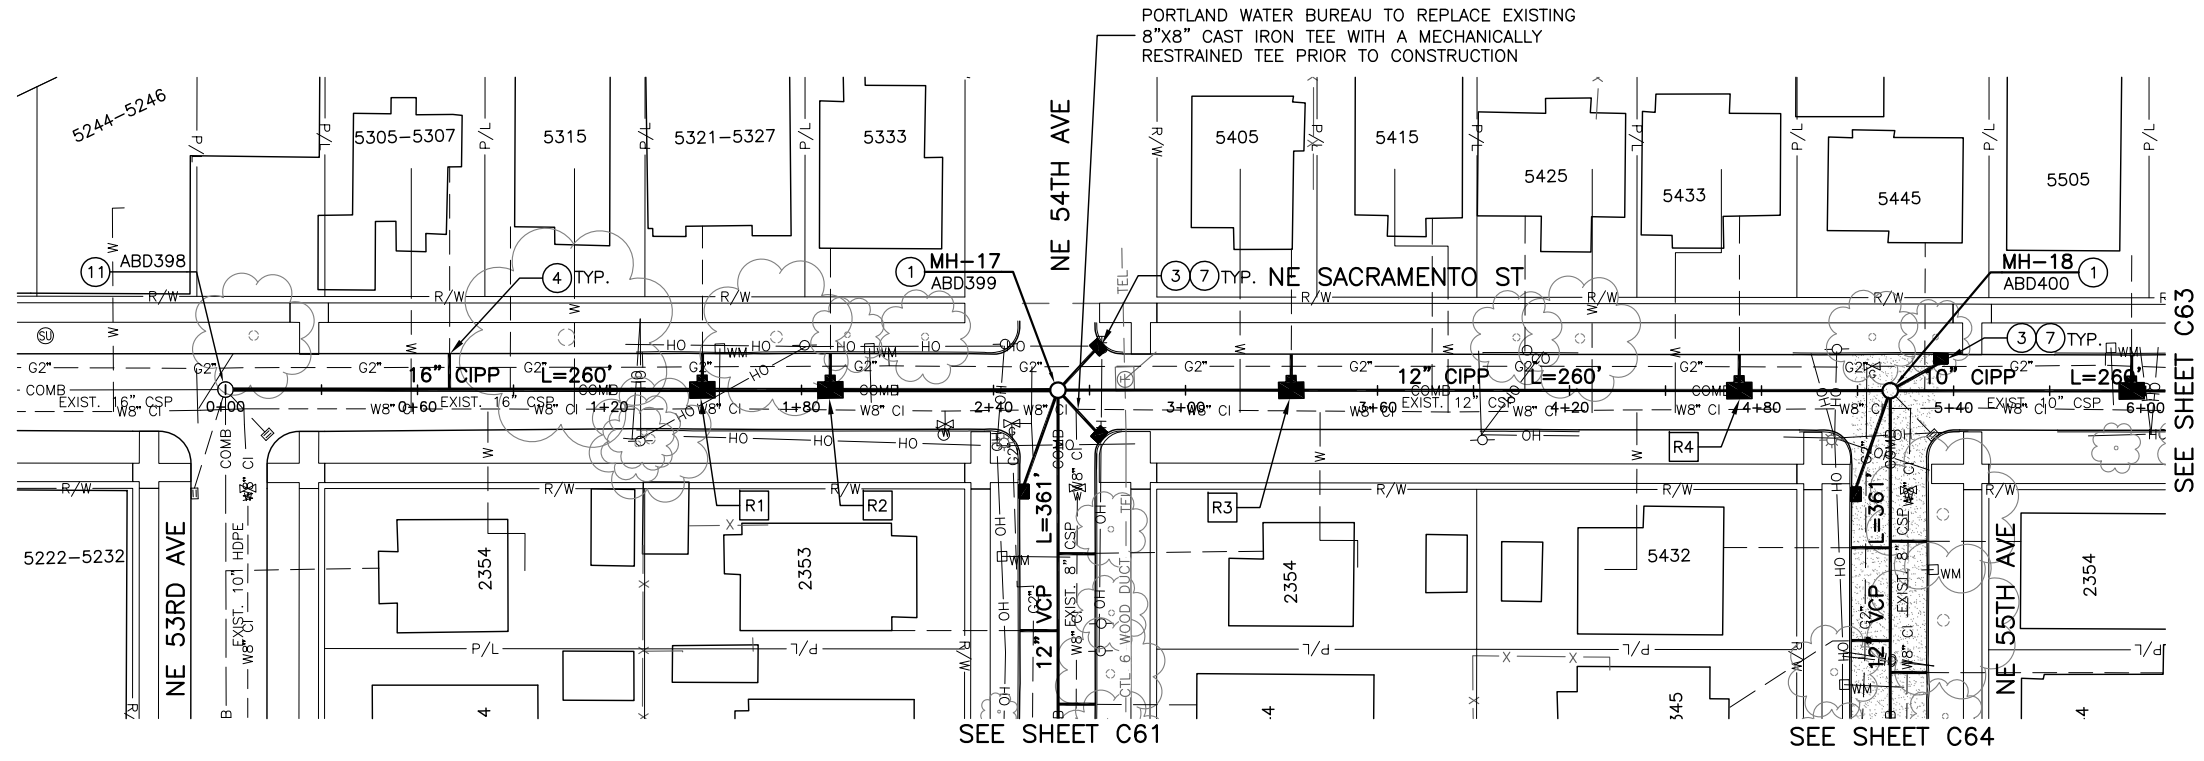

**CONSTRUCTION NOTES:**

- ① CONSTRUCT 48" MANHOLE
- ③ CONSTRUCT G2 INLET
- ⑦ CONSTRUCT INLET LEAD
- ⑪ REHABILITATE EXISTING MANHOLE

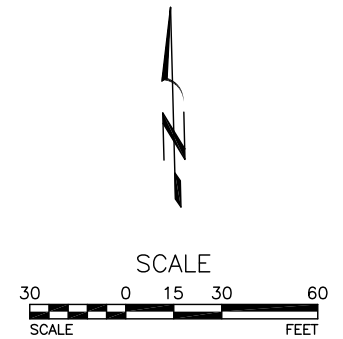

D:\CAD\_PROJECTS\E1XXXX\_Hollywood\DWG\E1XXXX\_C62.DWG 2/23/15 3:34:45 PM JAND

NO.	DATE	DESCRIPTION	APPD.

CITY OF PORTLAND  
**ENVIRONMENTAL SERVICES**

DESIGNED BY: \_\_\_\_\_ DATE APPD.: \_\_\_\_\_  
DRAWN BY: \_\_\_\_\_ PROGRAM MGR.: \_\_\_\_\_  
CHECKED BY: \_\_\_\_\_ CONST. MGR.: \_\_\_\_\_  
DESIGN MGR.: \_\_\_\_\_

REGISTERED PROFESSIONAL ENGINEER  
99999  
OREGON  
JUNE 01, 2000  
JOHN Q. ENGINEER  
Expires XX/XX/20XX

90%

**HOLLYWOOD - GRANT PARK  
SEWER REHABILITATION PROJECT**

PLAN AND PROFILE  
NE SACRAMENTO ST WEST OF SE 55TH AVE

1/4 SECTION  
3035  
JOB NO.  
E1XXXX  
SHEET NO.  
C62  
66 of 114

2\_SAMPLE\_PLAN-PROF\_PARTIAL-GRID.PDF