




LEFT ELEVATION
SCALE 1/4"=1'-0"

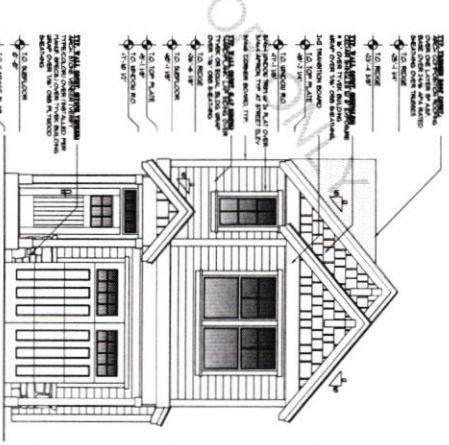

FRONT ELEVATION
SCALE 1/4"=1'-0"

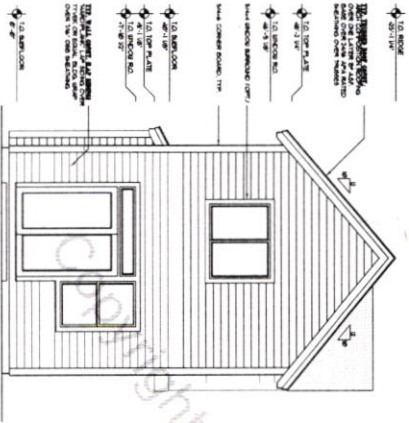

REAR ELEVATION
SCALE 1/4"=1'-0"

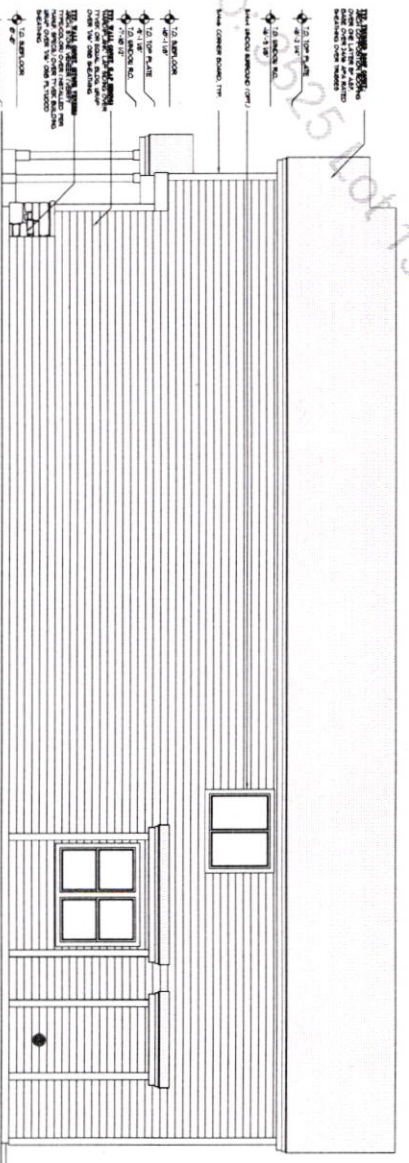


RIGHT ELEVATION
SCALE 1/4"=1'-0"

DATE: 07/20/07
L1

THIS IS A PRELIMINARY DRAWING. IT IS NOT TO BE USED FOR CONSTRUCTION. ANY CHANGES TO THE DRAWING MUST BE APPROVED BY SUNTEL DESIGN, INC. BEFORE PROCEEDING WITH CONSTRUCTION. SUNTEL DESIGN, INC. IS NOT RESPONSIBLE FOR ANY ERRORS OR OMISSIONS IN THIS DRAWING. THE CLIENT IS RESPONSIBLE FOR OBTAINING ALL NECESSARY PERMITS AND APPROVALS FROM THE LOCAL BUILDING DEPARTMENT AND OTHER AGENCIES. SUNTEL DESIGN, INC. IS NOT RESPONSIBLE FOR ANY DAMAGE TO PROPERTY OR PERSONS ARISING FROM THE USE OF THIS DRAWING.

Suntel
DESIGN · INC.
18965 Boones Ferry Road, Suite 202, Lake Oswego, Oregon 97035
Tel: (503) 624 0555 · Fax: (503) 624 0155
www.suntelhomesteadesign.com

FISH CONSTRUCTION Lot 19 SE 91ST AVE, PORTLAND
ROSEMONT
PLAN NUMBER 82508 1,577 SQ. FT. TOTAL

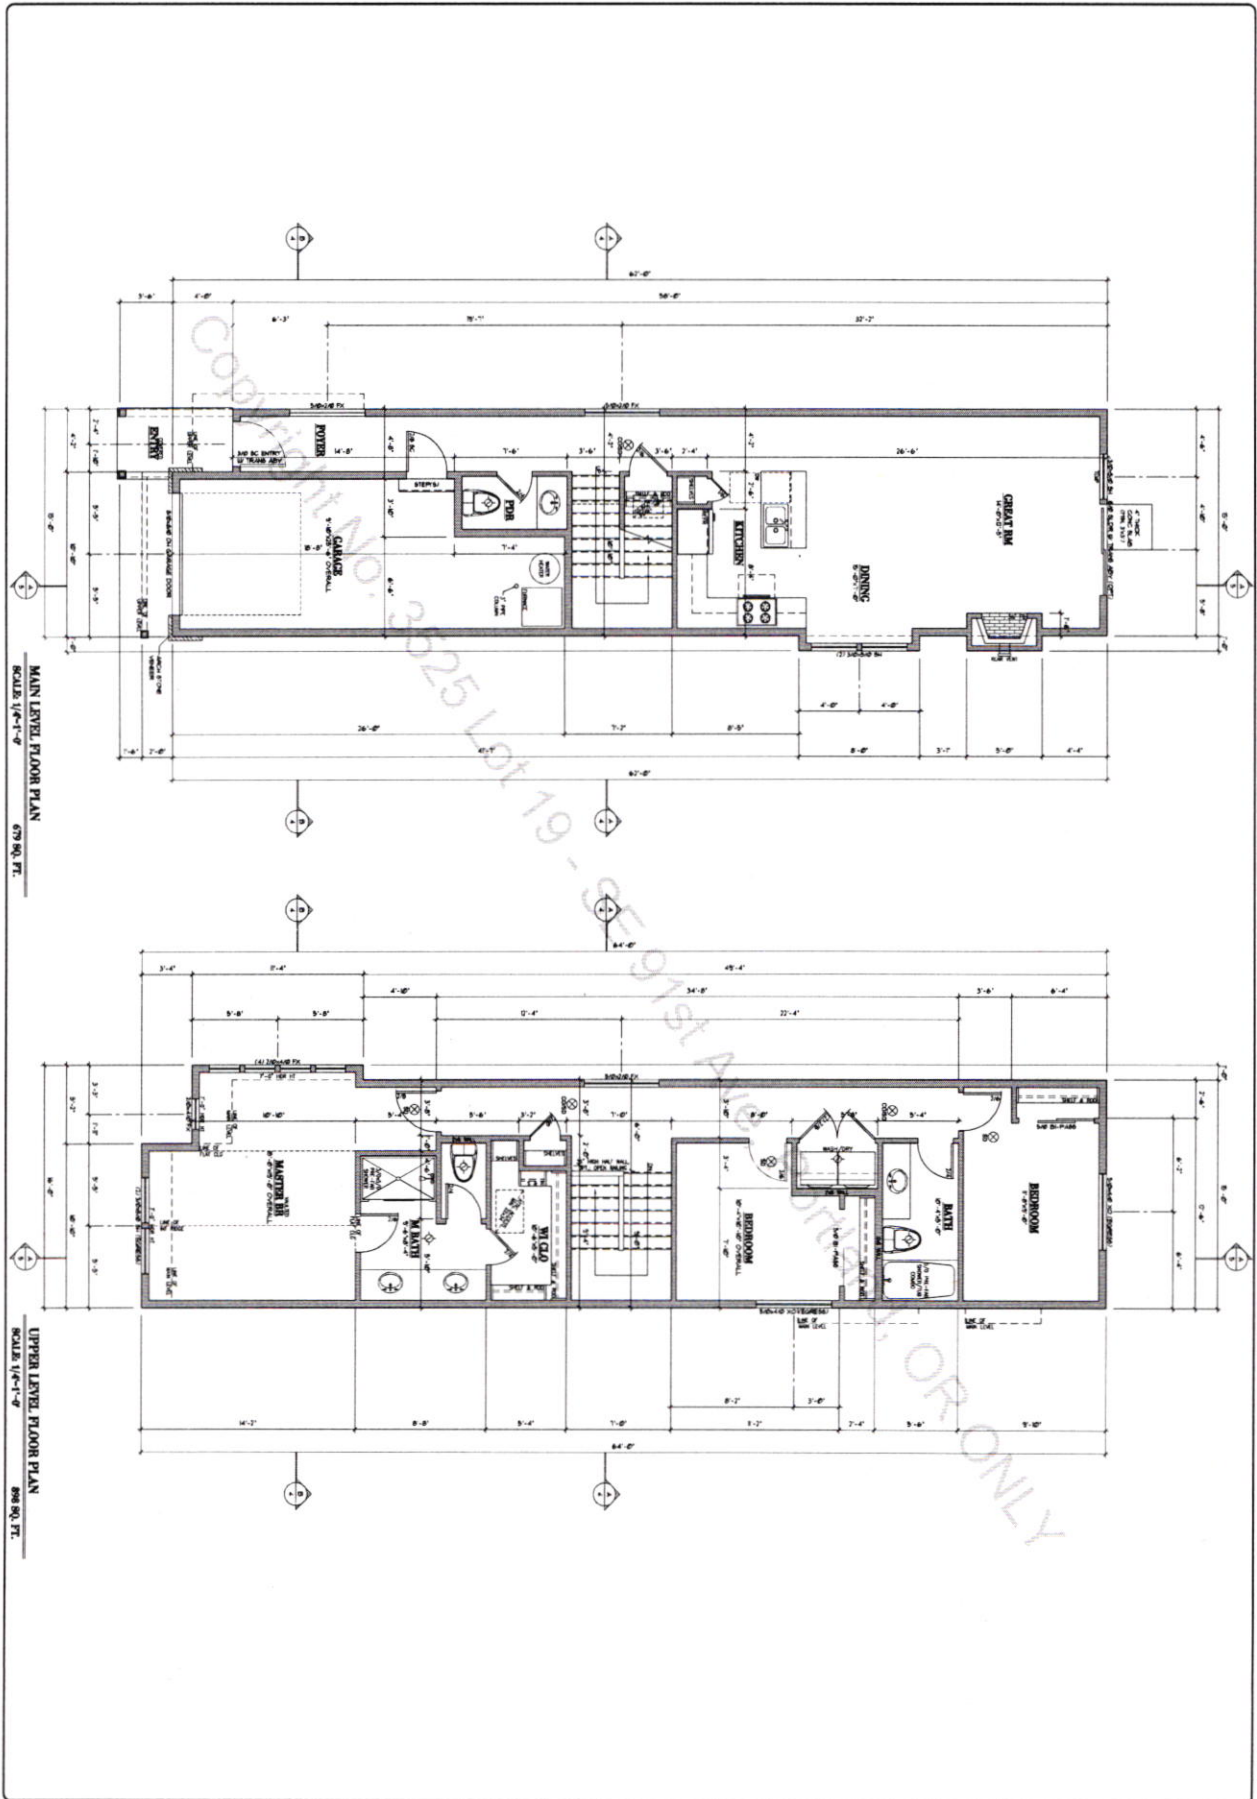

2

DATE: 02/26/2022

SCALE: 1/4" = 1'-0"

NOTES:

1. ALL DIMENSIONS ARE TO FACE UNLESS NOTED OTHERWISE.

2. FINISHES TO BE DETERMINED BY THE OWNER.

3. SEE SCHEDULE FOR MATERIALS AND FINISHES.

4. SEE MECHANICAL AND ELECTRICAL SCHEDULES FOR DETAILS.

5. SEE STRUCTURAL DRAWINGS FOR FOUNDATION AND FLOOR JOIST DETAILS.

6. SEE EXTERIOR ELEVATIONS FOR WINDOW AND DOOR SIZES AND PLACEMENT.

7. SEE LANDSCAPE ARCHITECTURE DRAWINGS FOR EXTERIOR DETAILS.

8. SEE CIVIL ENGINEERING DRAWINGS FOR UTILITY AND EROSION CONTROL DETAILS.

9. SEE GEOTECHNICAL REPORT FOR SOIL CONDITIONS AND FOUNDATION RECOMMENDATIONS.

10. SEE ENERGY CODE REQUIREMENTS FOR INSULATION AND WINDOW PERFORMANCE.

11. SEE LOCAL ORDINANCES FOR PERMITS AND REGULATIONS.

12. SEE ARCHITECT'S GENERAL CONDITIONS OF CONTRACT FOR TERMS AND CONDITIONS.


Suntel
 DESIGN, INC.
 16865 Boones Ferry Road, Suite 202, Lake Oswego, Oregon 97035
 Tel: (503) 624 9555 Fax: (503) 624 0155
 www.suntelhomadesign.com

FISH CONSTRUCTION Lot 19 SE 91ST AVE, PORTLAND
ROSEMONT
 PLAN NUMBER 82508 1,577 SQ. FT. TOTAL